


TENSION PER CONDUCTOR	
400kV BUSBARS	8 kN
400kV STRINGERS	4 kN
EARTHWIRE	2 kN
132kV BUSBARS	4,5 kN
132kV STRINGERS	4,5 kN

BUSBAR CONDUCTOR SIZES	
400kV BUSBARS	2x800mm ²
132kV BUSBARS	200 x 6WT AL. TUBE

**FINAL DESIGN
FOR CONSTRUCTION**

REV	REVISION DESCRIPTION	DATE	BY	CHKD	APPD	DATE
1	130kV BUSBAR EXTENDED BY 6 BAYS AND 132kV FEEDER 14" x EQUIPPED	9/10/15	SC	SZ	RR	634/2536 GUARD HOUSE-TELEC
2	132kV YARD, 132kV FEEDERS 1 & 2 ADDED	6/12/2015	SC	PS	RR	632/2525 GUARD HOUSE
3	132kV YARD, 132kV FEEDERS 1 & 2 ADDED	6/12/2015	SC	PS	RR	5626 CAP BANK DRAINAGE
4	132kV YARD, 132kV FEEDERS 1 & 2 ADDED	6/12/2015	SC	PS	RR	5625 CAP BANK DRAINAGE
5	132kV YARD, 132kV FEEDERS 1 & 2 ADDED	6/12/2015	SC	PS	RR	632/2030 CONTROL SITE PLAN
6	132kV YARD, 132kV FEEDERS 1 & 2 ADDED	6/12/2015	SC	PS	RR	5508 ST WORK MARKING PLAN
7	132kV YARD, 132kV FEEDERS 1 & 2 ADDED	6/12/2015	SC	PS	RR	5508 TERRACE SOL & DRAINAGE
8	132kV YARD, 132kV FEEDERS 1 & 2 ADDED	6/12/2015	SC	PS	RR	5508 TERRACE SOL & DRAINAGE
9	132kV YARD, 132kV FEEDERS 1 & 2 ADDED	6/12/2015	SC	PS	RR	5508 TERRACE SOL & DRAINAGE
10	132kV YARD, 132kV FEEDERS 1 & 2 ADDED	6/12/2015	SC	PS	RR	5508 TERRACE SOL & DRAINAGE
11	132kV YARD, 132kV FEEDERS 1 & 2 ADDED	6/12/2015	SC	PS	RR	5508 TERRACE SOL & DRAINAGE
12	132kV YARD, 132kV FEEDERS 1 & 2 ADDED	6/12/2015	SC	PS	RR	5508 TERRACE SOL & DRAINAGE
13	132kV YARD, 132kV FEEDERS 1 & 2 ADDED	6/12/2015	SC	PS	RR	5508 TERRACE SOL & DRAINAGE
14	132kV YARD, 132kV FEEDERS 1 & 2 ADDED	6/12/2015	SC	PS	RR	5508 TERRACE SOL & DRAINAGE
15	132kV YARD, 132kV FEEDERS 1 & 2 ADDED	6/12/2015	SC	PS	RR	5508 TERRACE SOL & DRAINAGE
16	132kV YARD, 132kV FEEDERS 1 & 2 ADDED	6/12/2015	SC	PS	RR	5508 TERRACE SOL & DRAINAGE
17	132kV YARD, 132kV FEEDERS 1 & 2 ADDED	6/12/2015	SC	PS	RR	5508 TERRACE SOL & DRAINAGE
18	132kV YARD, 132kV FEEDERS 1 & 2 ADDED	6/12/2015	SC	PS	RR	5508 TERRACE SOL & DRAINAGE
19	132kV YARD, 132kV FEEDERS 1 & 2 ADDED	6/12/2015	SC	PS	RR	5508 TERRACE SOL & DRAINAGE
20	132kV YARD, 132kV FEEDERS 1 & 2 ADDED	6/12/2015	SC	PS	RR	5508 TERRACE SOL & DRAINAGE
21	132kV YARD, 132kV FEEDERS 1 & 2 ADDED	6/12/2015	SC	PS	RR	5508 TERRACE SOL & DRAINAGE
22	132kV YARD, 132kV FEEDERS 1 & 2 ADDED	6/12/2015	SC	PS	RR	5508 TERRACE SOL & DRAINAGE

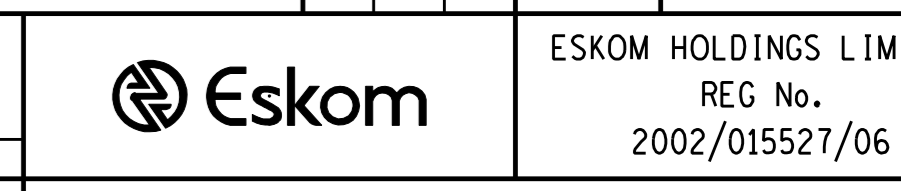

**KRONOS
KEY PLAN**

SCALE 1:750
SHEET NUMBER 0
REVISION 7